



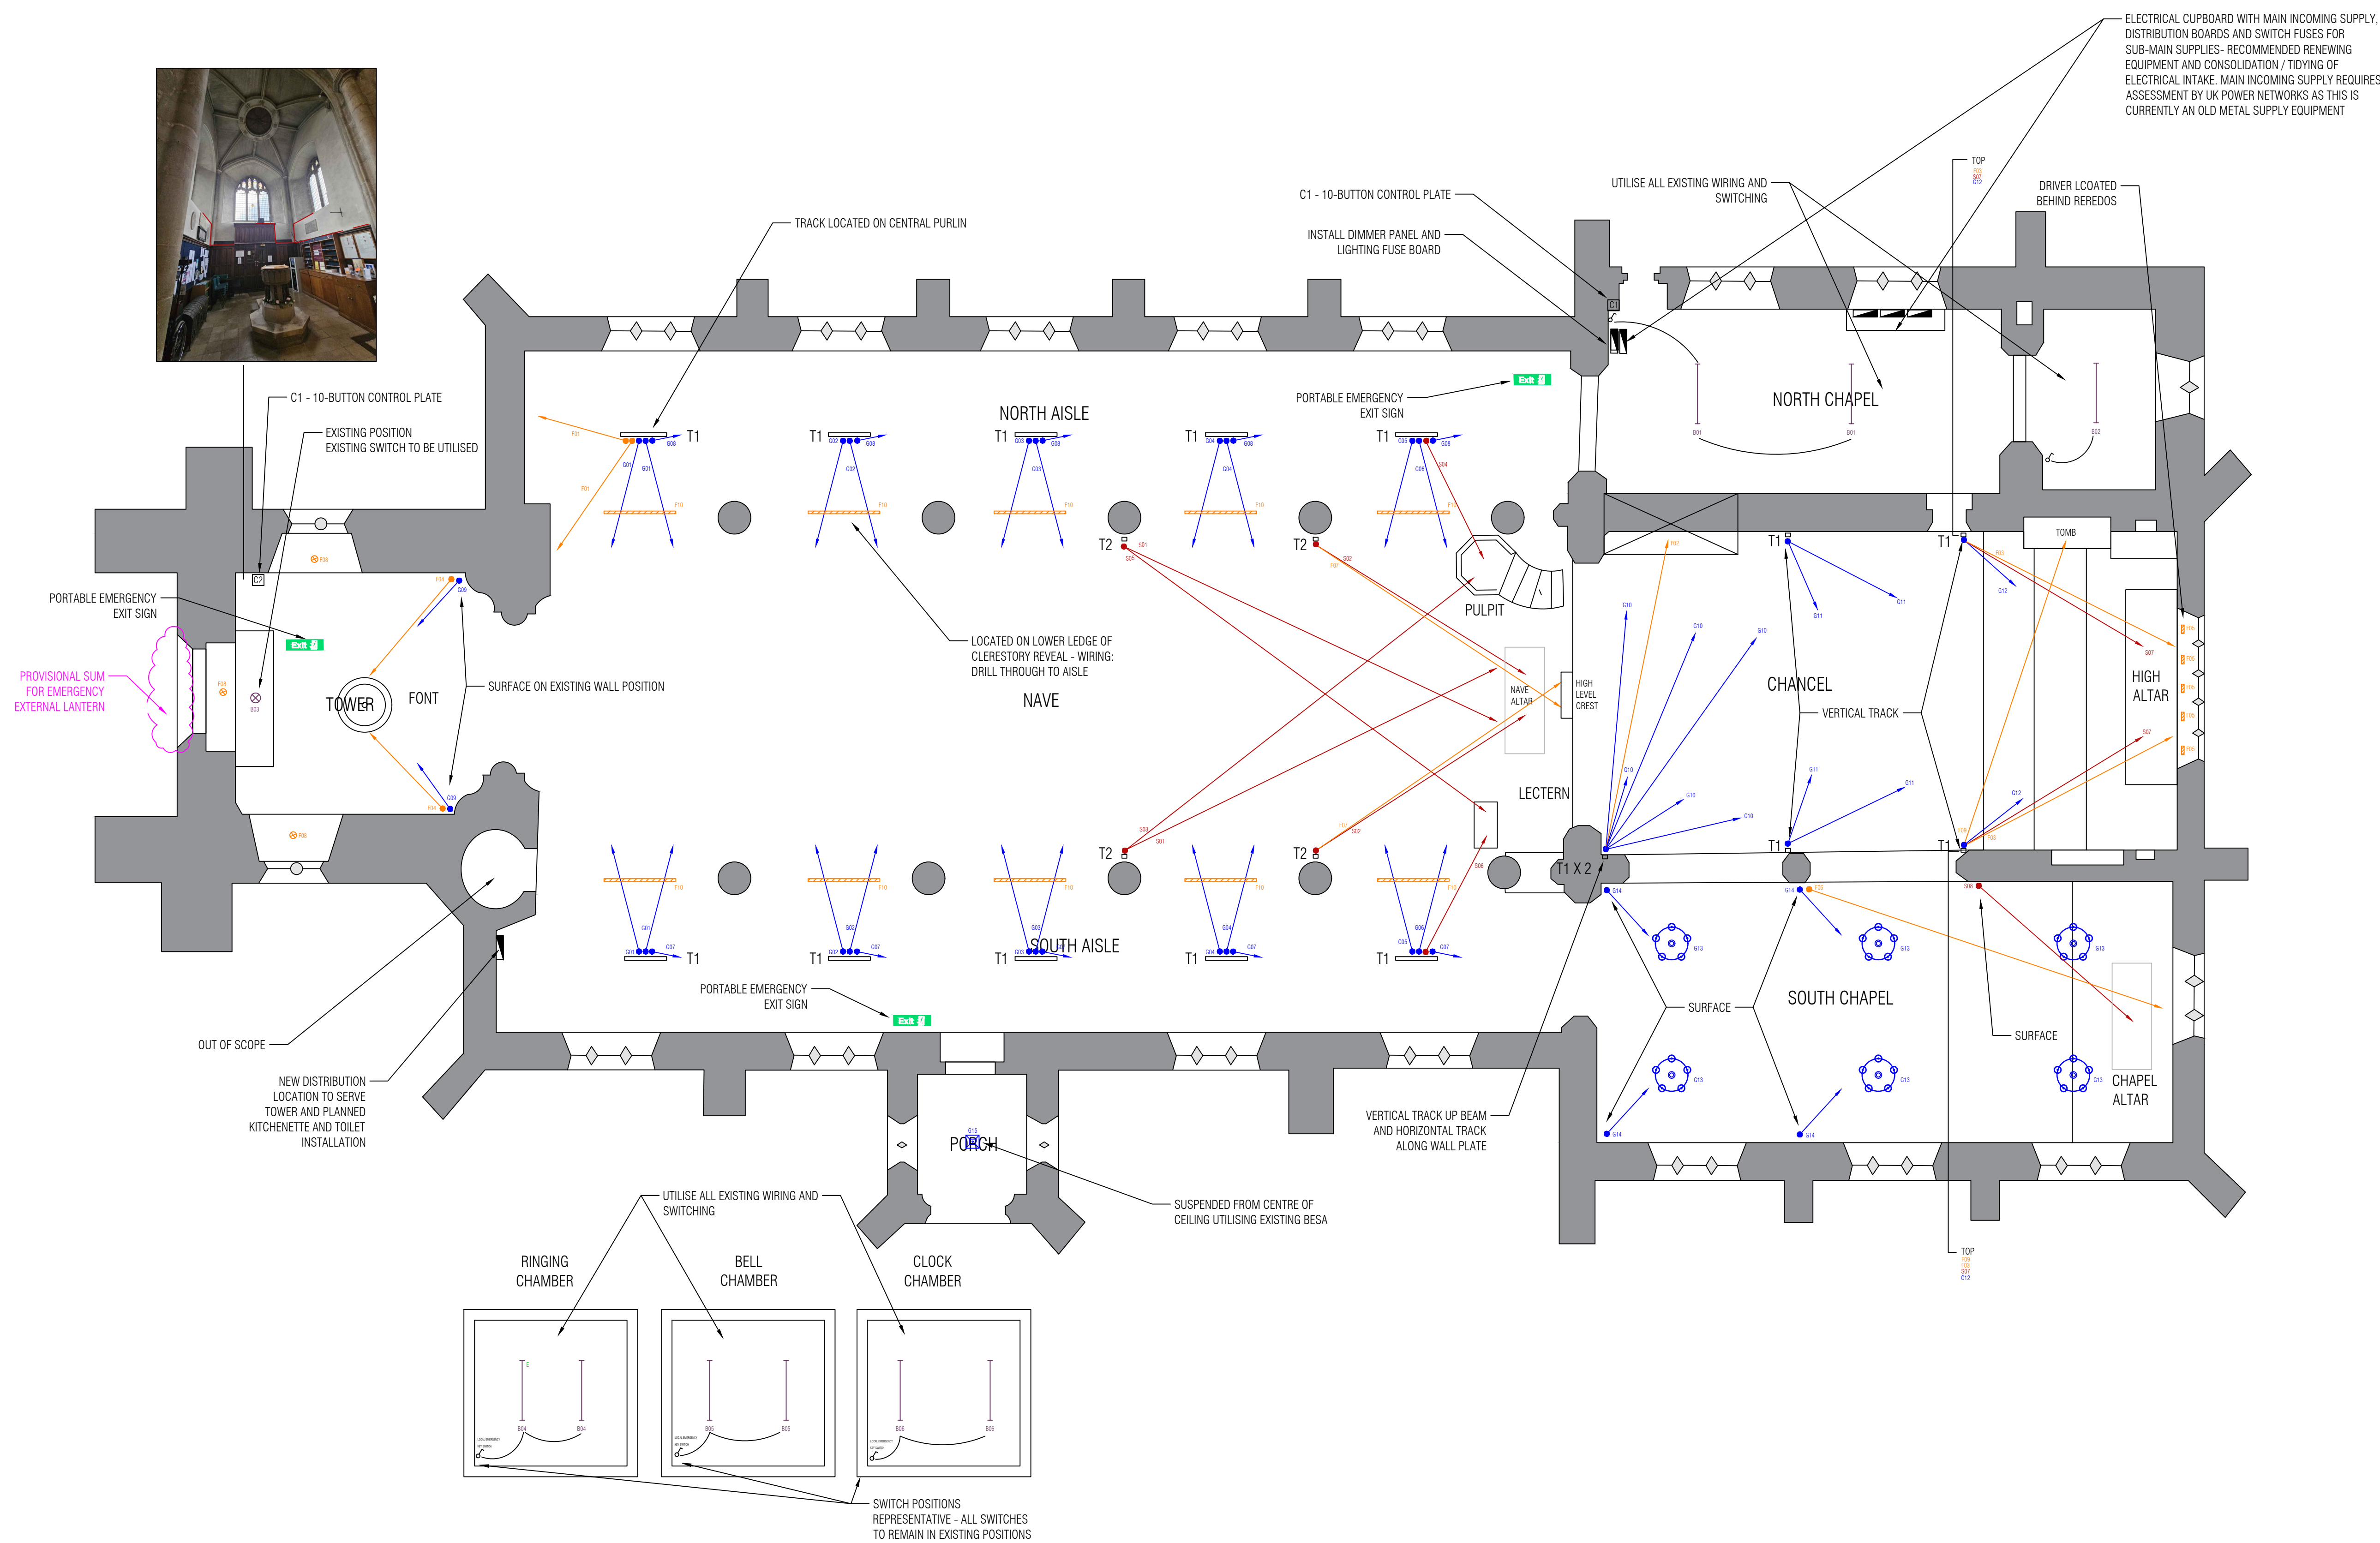

	Rev.	Drawn by	
Copyright : CES Lighting and Electrical Specialists			
Standard Notes 1. DO NOT SCALE THIS DRAWING. WORK TO DIMENSIONS GIVEN. 2. ALL DIMENSIONS TO BE VERIFIED FROM SITE MEASUREMENT 3. DIMENSIONS ARE IN MILLIMETRES UNLESS OTHERWISE STATED.			
LIGHTING KEY:		SMALL POWER KEY:	
SINGLE GANG SWITCH PULL CORD SWITCH DOUBLE GANG SWITCH TRIPLE GANG SWITCH SINGLE TWO WAY SWITCH DOUBLE TWO WAY SWITCH TRIPPLE TWO WAY SWITCH ROTARY DIMMER SWITCH SINGLE SOCKET SINGLE SOCKET FOR LAMP DOUBLE SOCKET WEATHERPROOF SOCKET DISTRIBUTION BOARD MOTION SENSOR WALL MOUNTED PHOTOCELL 24 hr TIMECLOCK LIGHTNING CONTROL POINT EXTRACT FAN HEAT OR SMOKE DETECTOR FIRE ALARM BELL FIRE ALARM STATION FIRE ALARM CENTRAL STATION STROBE FIRE ALARM SOUNDER			
NOTES:			
DRAWING STAGE AND STATUS		☐ TENDER ☐ CONSTRUCTION ☐ AS BUILD	
PROPOSAL ☐		☐ RIBA 2	
DRAFT ☐		☐ RIBA 3	
APPROVAL ☐		☒ RIBA 4	
FINAL ☒			
Ces LIGHTING & ELECTRICAL DESIGN INSTALL MAINTAIN Crusader Hall, 25c Stanley Park Rd, Wallington, Surrey SM6 0HL Office: 020 8655 2816 Email: office@ces-engineers.co.uk Website: www.ces-lighting.co.uk			
Client ST MARYS CHURCH CHESHUNT			
Project CES/7970			
Drawing Title PROPOSED LIGHTNG LAYOUT INTERNAL LIGHTING			
Dig No. 7970-L01			Revision 3
Scale NTS@A1	Date 18/12/2025	Engineer RS	Checked RS Drawing of 1/3

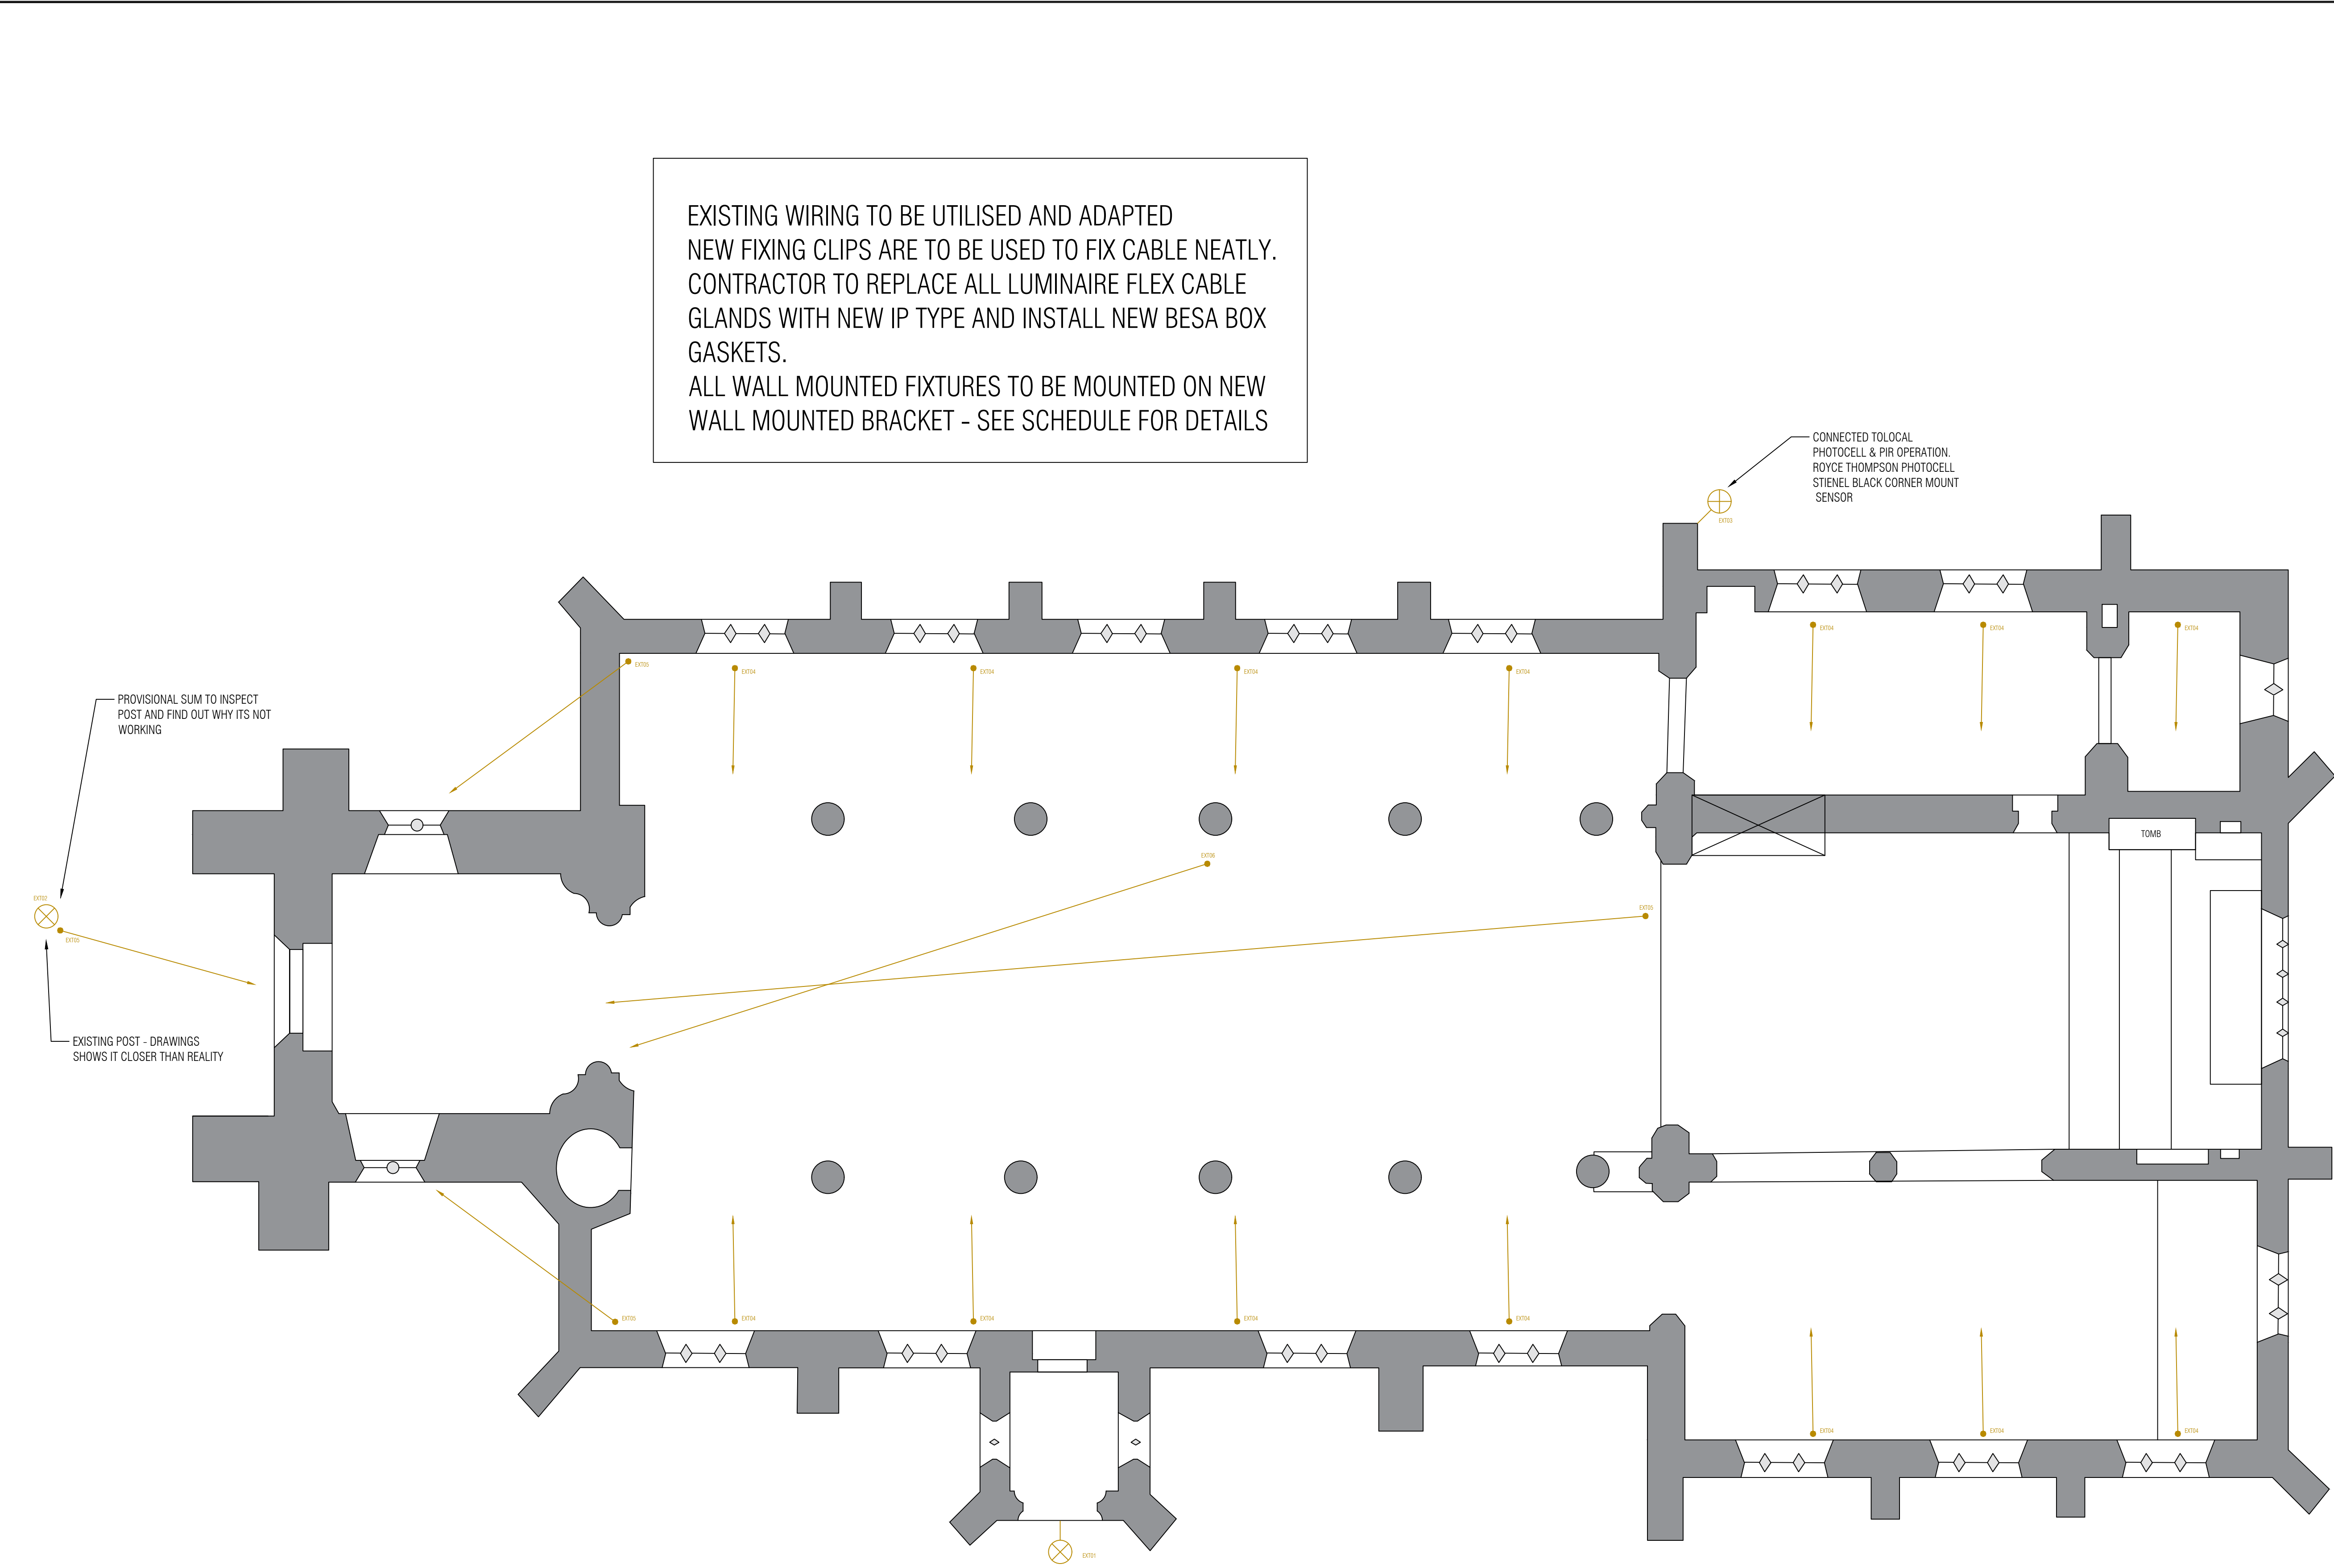

EXISTING WIRING TO BE UTILISED AND ADAPTED
NEW FIXING CLIPS ARE TO BE USED TO FIX CABLE NEATLY.
CONTRACTOR TO REPLACE ALL LUMINAIRE FLEX CABLE
GLANDS WITH NEW IP TYPE AND INSTALL NEW BESA BOX
GASKETS.
ALL WALL MOUNTED FIXTURES TO BE MOUNTED ON NEW
WALL MOUNTED BRACKET - SEE SCHEDULE FOR DETAILS

Rev.	Drawn by			
Copyright : CES Lighting and Electrical Specialist				
Standard Notes 1. DO NOT SCALE THIS DRAWING. WORK TO DIMENSIONS GIVEN. 2. ALL DIMENSIONS TO BE VERIFIED FROM SITE MEASUREMENT. 3. DIMENSIONS ARE IN MILLIMETRES UNLESS OTHERWISE STATED.				
LIGHTING KEY:		SMALL POWER KEY:		
	GENERAL LIGHTING		SINGLE GANG SWITCH	
	FEATURE LIGHTING		PULL CORD SWITCH	
	SERVICE LEADING		DOUBLE GANG SWITCH	
	UP-LIGHTING		TRIPLE GANG SWITCH	
	EMERGENCY LIGHTING		SINGLE TWO WAY SWITCH	
	EXTERNAL LIGHTING		DOUBLE TWO WAY SWITCH	
	LOCAL SWITCHED LIGHTING		TRIPLE TWO WAY SWITCH	
			ROTARY DIMMER SWITCH	
			SINGLE SOCKET	
			SINGLE SOCKET FOR LAMP	
			DOUBLE SOCKET	
			WEATHERPROOF SOCKET	
			DISTRIBUTION BOARD	
			MOTION SENSOR	
			WALL MOUNTED PHOTOCELL	
			24 hr TIMECLOCK	
			LIGHTING CONTROL POINT	
			EXTRACT FAN	
			HEAT OR SMOKE DETECTOR	
			FIRE ALARM BELL	
			FIRE ALARM STATION	
			FIRE ALARM CENTRAL STATION	
			STROBE	
			FIRE ALARM SOUNDER	
NOTES:				
DRAWING STAGE AND STATUS PROPOSAL ☐ DRAFT ☐ APPROVAL ☐ FINAL ☒ TENDER ☐ CONSTRUCTION ☐ AS BUILD ☐ RIBA 2 ☐ RIBA 3 ☐ RIBA 4 ☒				
 ces LIGHTING & ELECTRICAL DESIGN INSTALL MAINTAIN Crusader Hall, 25c Stanley Park Rd, Wallington, Surrey SM6 6HL Office: 020 8835 2816 Email: office@ces-engineers.co.uk Website: www.ces-lighting.co.uk				
Client ST MARYS CHURCH CHESHUNT				
Project CES/7970				
Drawing Title PROPOSED LIGHTING LAYOUT EXTERNAL LIGHTING				
Dwg No. 7970-L02		Revision 3		
Scale NTS@A1	Date 18/12/2025	Engineer RS	Checked RS	Drawing of 2/3

